




ANNEXURE C

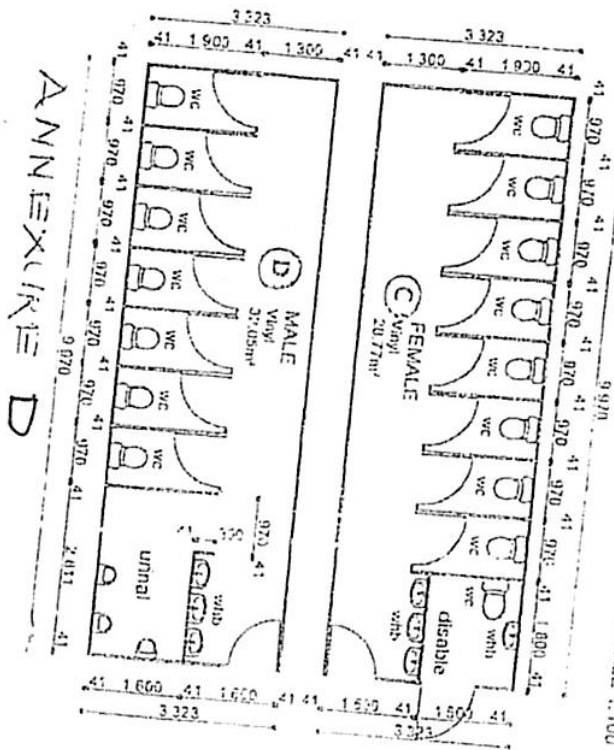

TYPICAL SECTION
SCALE 1:100

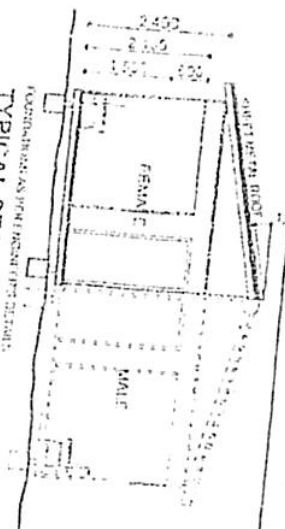


ANNEXURE E

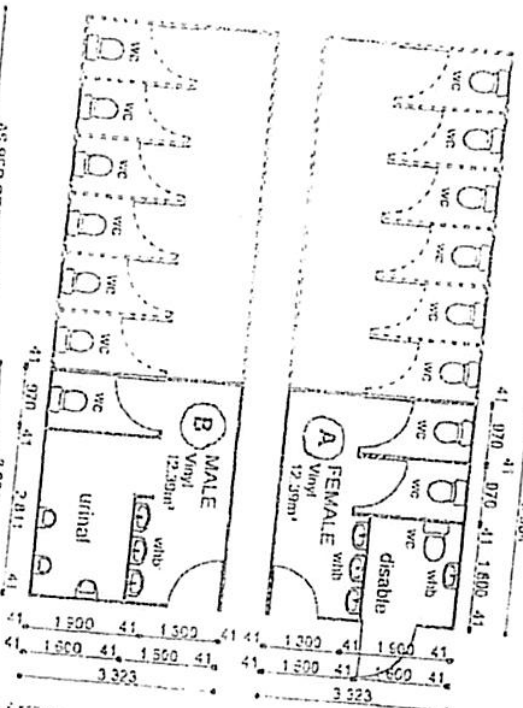


ANNEXURE F

28 PER REQUIREMENT
FULL MODULE
STANDARD MODULE
ABLUTIONS BLOCKS
DRAWN BY: NN

ANNEXURE F

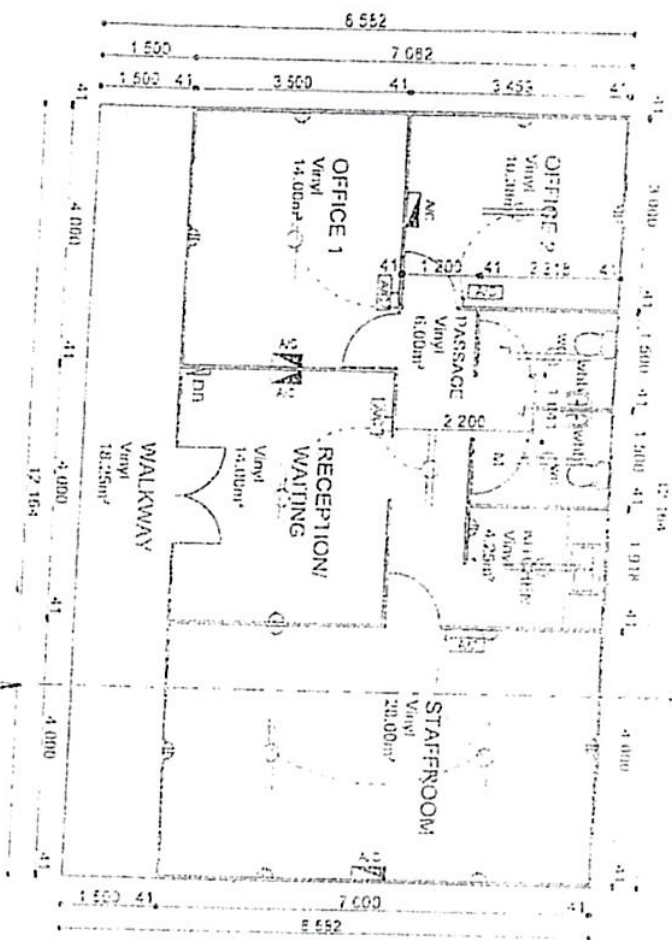

GROUND FLOOR LAYOUT
SCALE 1:100

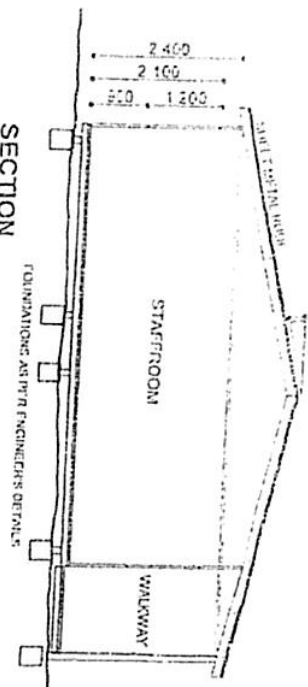

SECTION
SCALE 1:100

ELECTRICAL LEGEND


	DB BOARD
	A/C WALL MOUNTED CONTROL
	WALL MOUNTED A/C UNIT
	CEILING MOUNTED FLOURESCENT LIGHT
	DOUBLE WALL PLUG
	SINGLE LIGHT SWITCH
	DOUBLE LIGHT SWITCH

TYPICAL PLAN : ADMINISTRATION BLOCK

DRAWN BY: NN

MOBILE CLASSROOM - PLAN
SCALE 1:50


NOTE:
DRAWINGS TO BE READ IN CONJUNCTION WITH

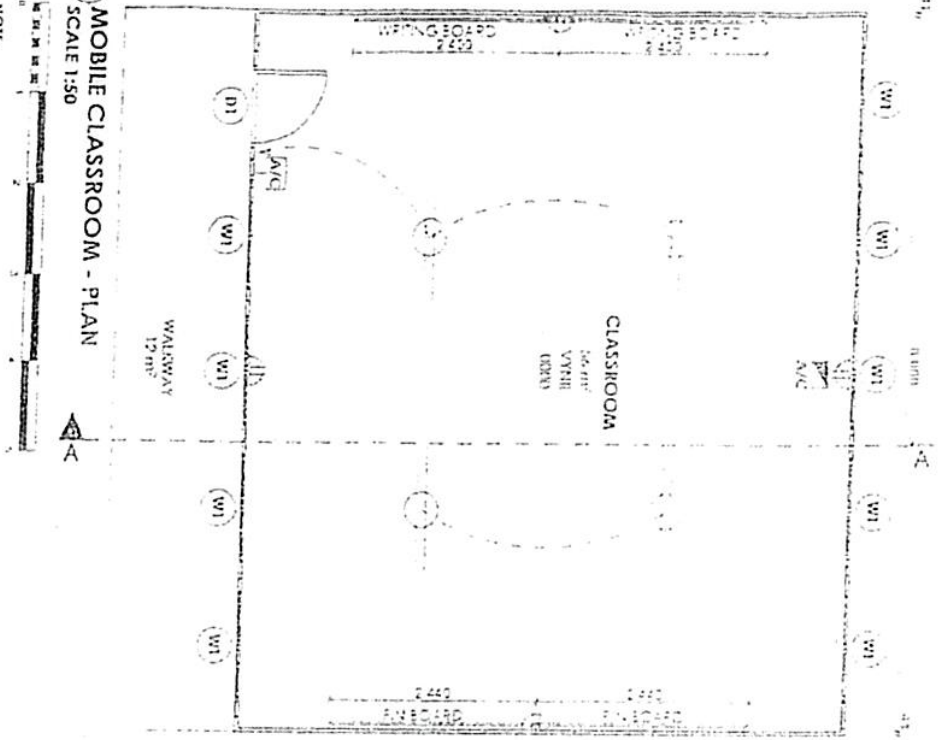

TYPICAL LAYOUT FOR MOBILE/PREFABRICATED CLASSROOM
DRAWING NO. MDO0001-SH-001 DRAWN BY J. NE

MOBILE CLASSROOM - SECTION AA
SCALE 1:50

FOUNDATIONS AS PER ENGINEER

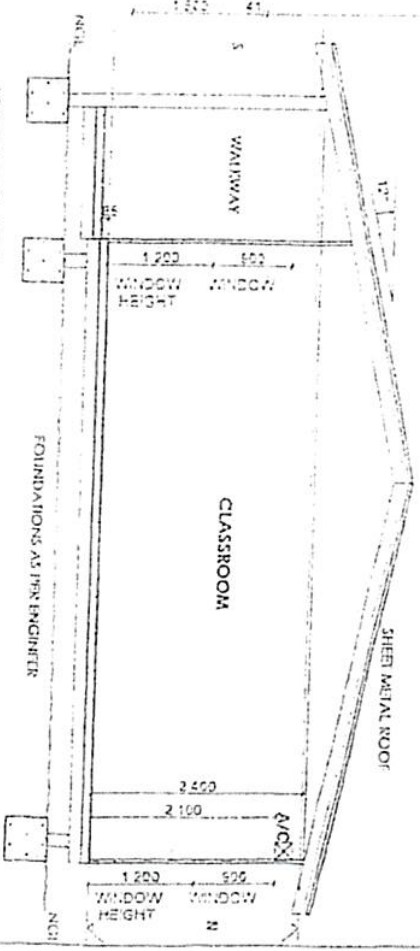

ELECTRICAL LEGEND

AWC	A/C WALL MOUNTED CONTROL
W1	WALL MOUNTED A/C UNIT
D1	DOOR WITH MOUNTED 7 FOOT HIGH SCRIB FOOT
SW	SINGLE SWITCH

W1 - HEIGHT 900mm x LENGTH 1500mm ALUMINIUM OR STEEL FRAME
D1 - HEIGHT 2100mm x LENGTH 900mm STANDARD EXPANSAL WOODEN DOOR